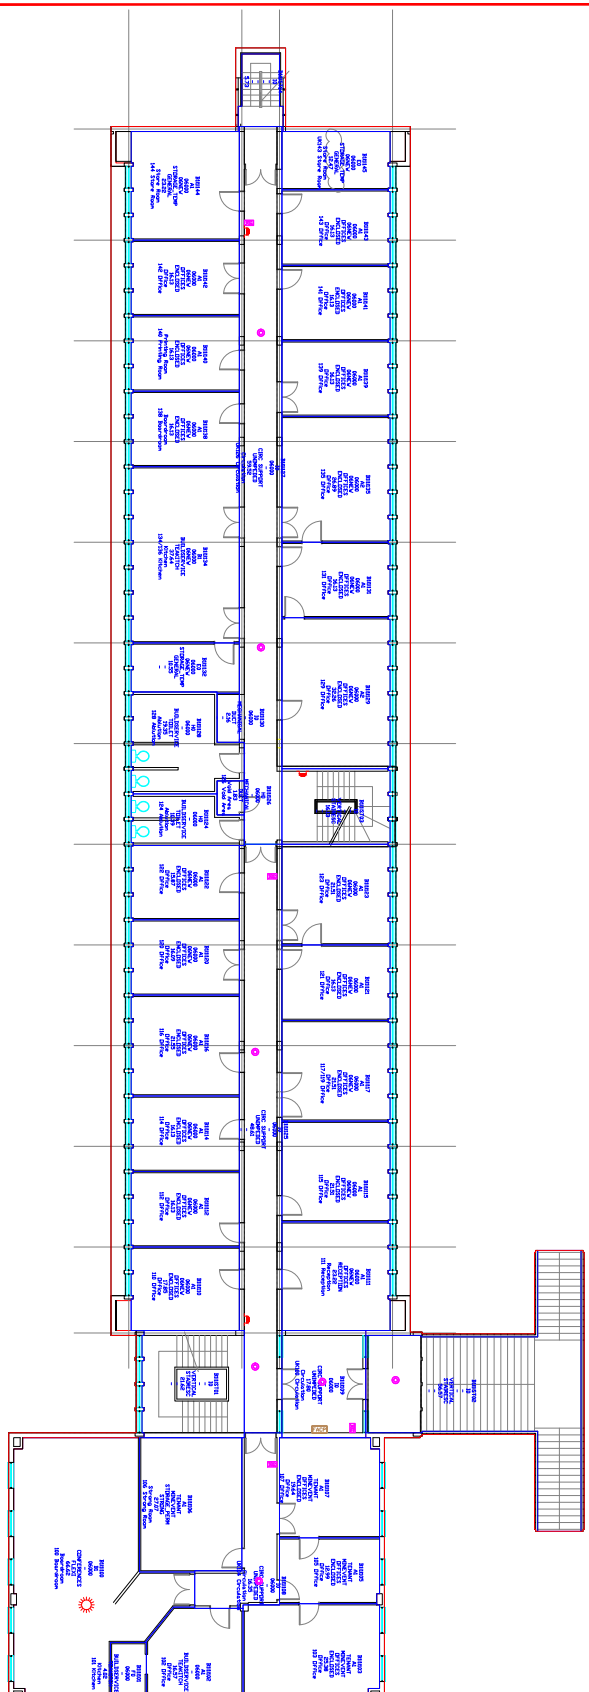
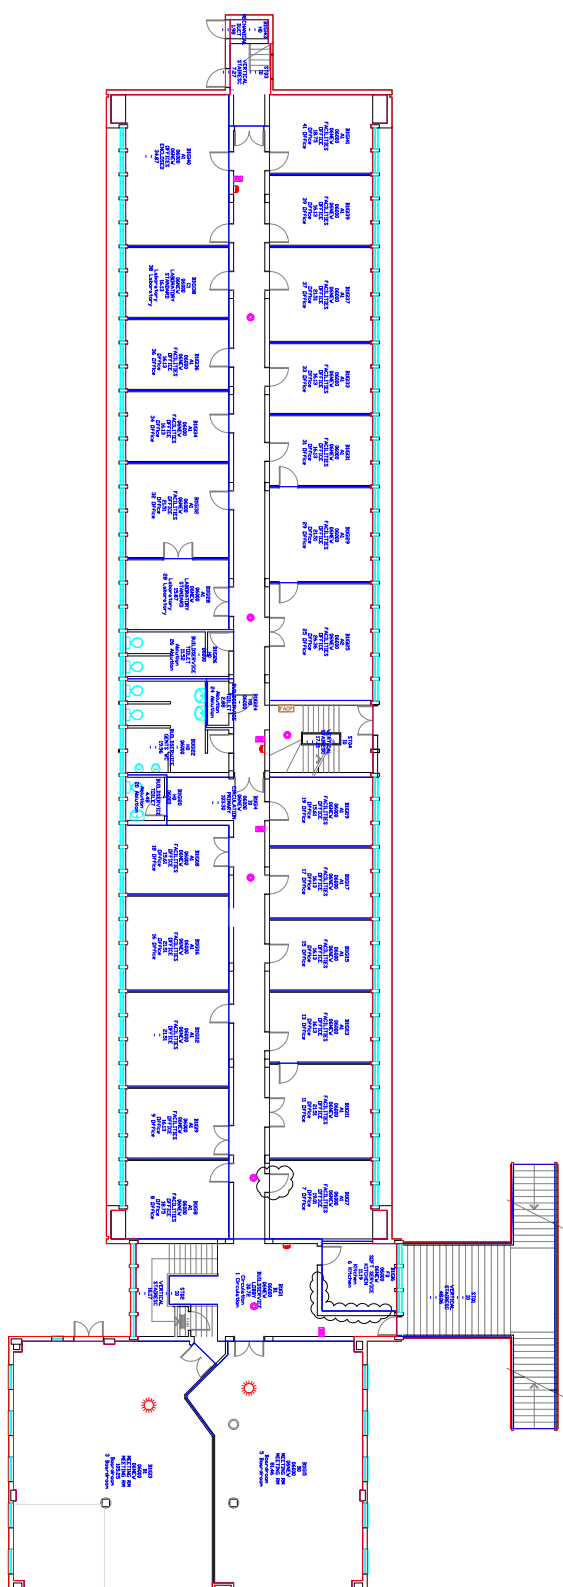
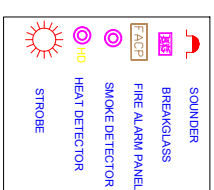




Rev.	Date	Description of Revision	By	Appr.
1	26.10.16	UPDATED AS BUILT DRAWING	A	

Project Description:	 <i>our future through science</i> CSIR's facilities are located at 627 Main Road Pretoria
Scale:	CSIR CAMPUS JOHANNESBURG
1:50 / A1	
Document 136	Date: 26/0/2016



1	25 JUL 2016 10:45:02 AM BILU 1.0258960	Acct	
2		Cont	
3			
4			
5			
100			


SOUNDER


BREAKGLASS

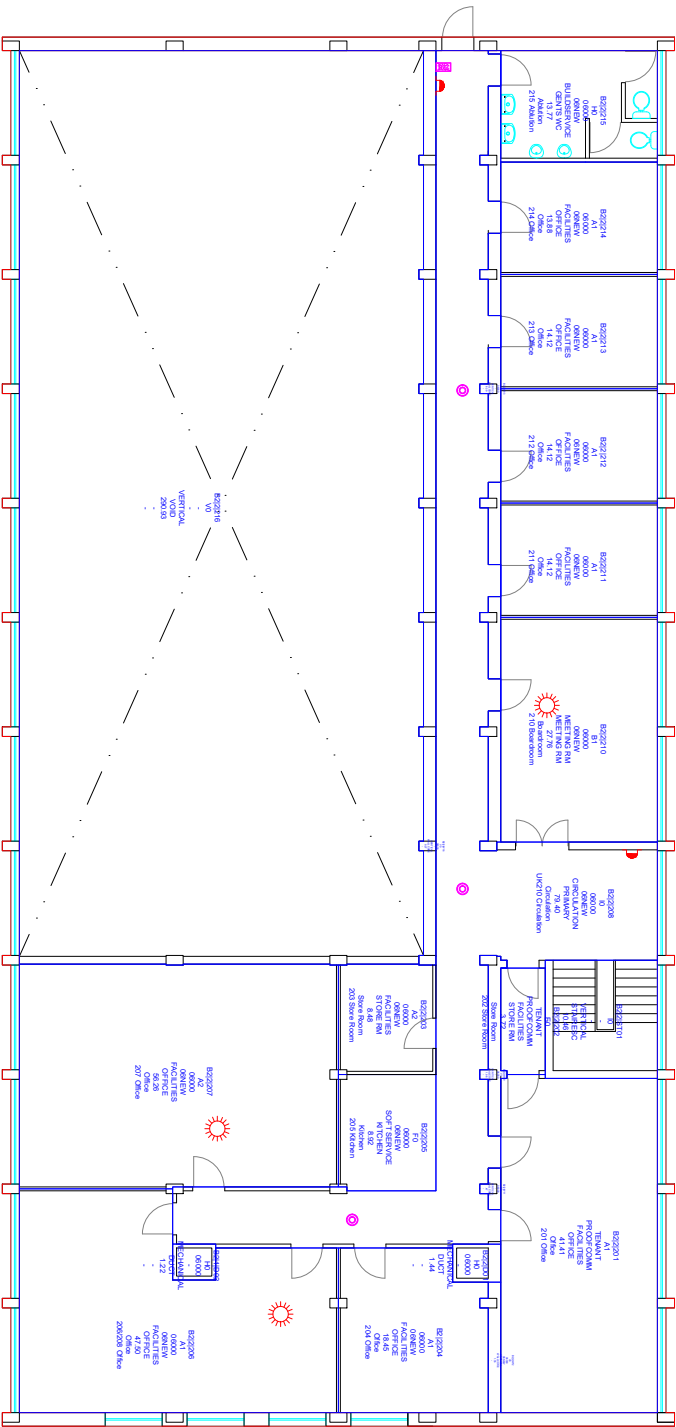

FACP


FIRE ALARM PANEL


SMOKE DETECTOR


HEAT DETECTOR


HEAT DETECTOR



25PB002
2
Internal
685.44



CSIR Building
027 Moring Road
Pretoria

Project Description:
CSIR CAMPUS
JOHANNESBURG

Scale:
1:150 / A1
Date:
28/10/2016

Document Title:
BUILDING 2
SECOND FLOOR PLAN

Drawn by:
25FP2
1/1
1
A1

BUILDING 2
SECOND FLOOR PLAN
SCALE 1:100




SOUNDER


BREAKGLASS

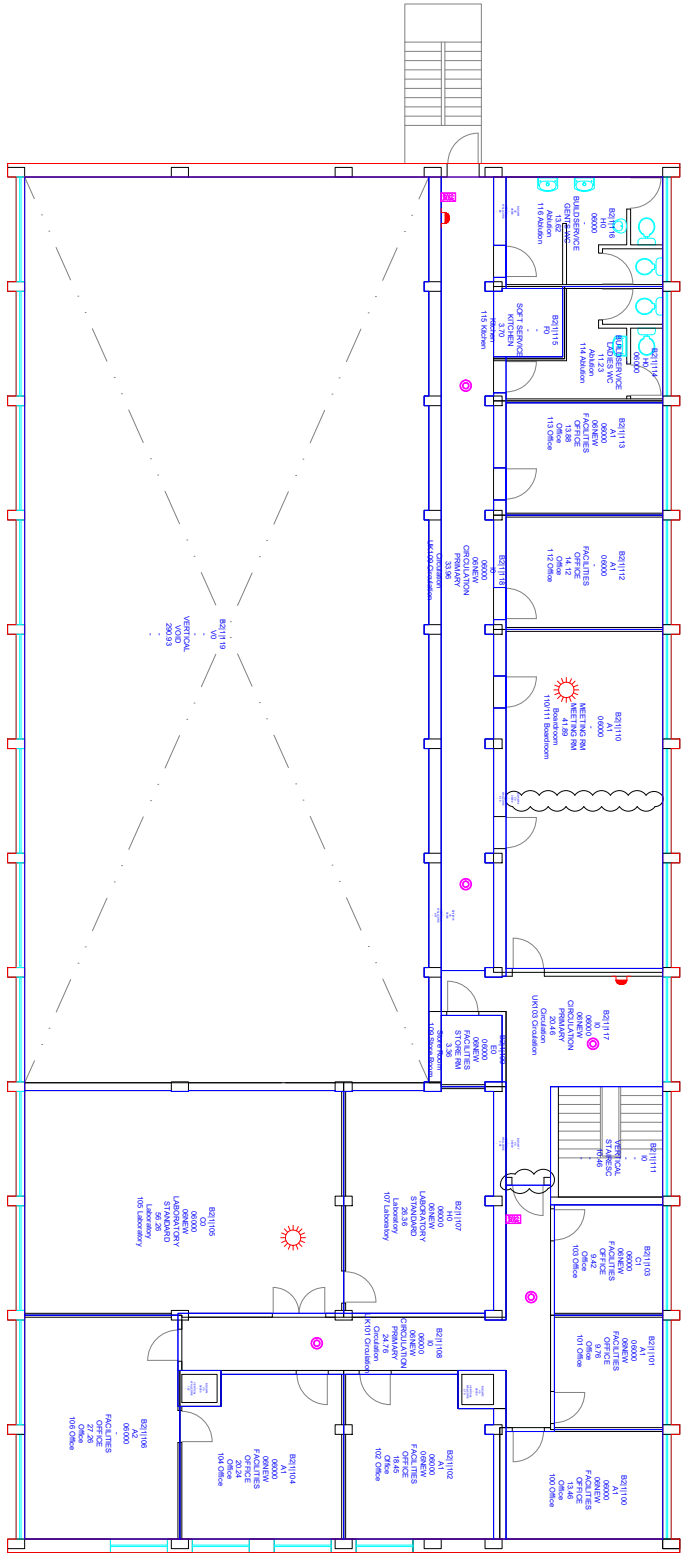

FACP


FIRE ALARM PANEL


SMOKE DETECTOR


HEAT DETECTOR


STROBE



25PB002
1
Internal
685.44

25PB002
External
718.57



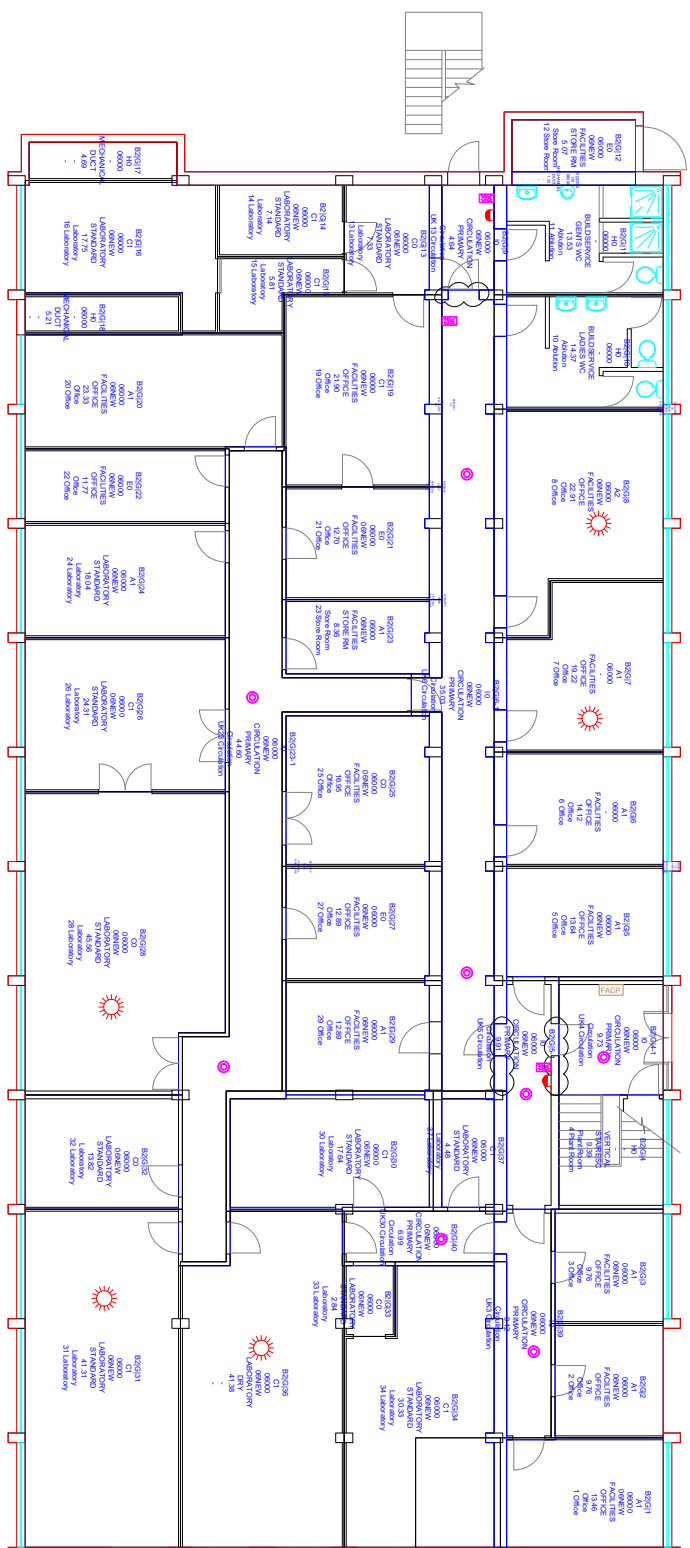
CSIR Building
027 Moring Road
Pretoria

Project Description:
CSIR CAMPUS
JOHANNESBURG

Scale:
1:150 / A1
Date:
28/10/2016

Document Title:
BUILDING 2
FIRST FLOOR PLAN

Drawn by:
25FP1
1/1
1
A1



A diagram of a fire alarm control panel. It features a central rectangular unit labeled 'FACP' (Fire Alarm Control Panel). To the left of the FACP are two circular detectors: a 'SMOKE DETECTOR' (top) and a 'HEAT DETECTOR' (bottom). To the right of the FACP are three components: a 'SOUNDER' (top), a 'BREAKGLASS' (middle), and a 'FIRE ALARM PANEL' (bottom). The entire panel is enclosed in a blue border.

[illegible]

ଜି.ଆର୍.

our future through science

CSIR CAMPUS
JOHANNESBURG

Scale:	Date:
1:150 / A1	26/10/2016

BUILDING 2
GROUND FLOOR PLAN

Drawing Number

2FP0	1/1	1
	Empty State	
A1		